


# YOGA EXPO 2008

TOWN SQUARE HOECKER

MELBOURNE SHOWROUND

SHOW DATES

HOECKER  
EXTENSION

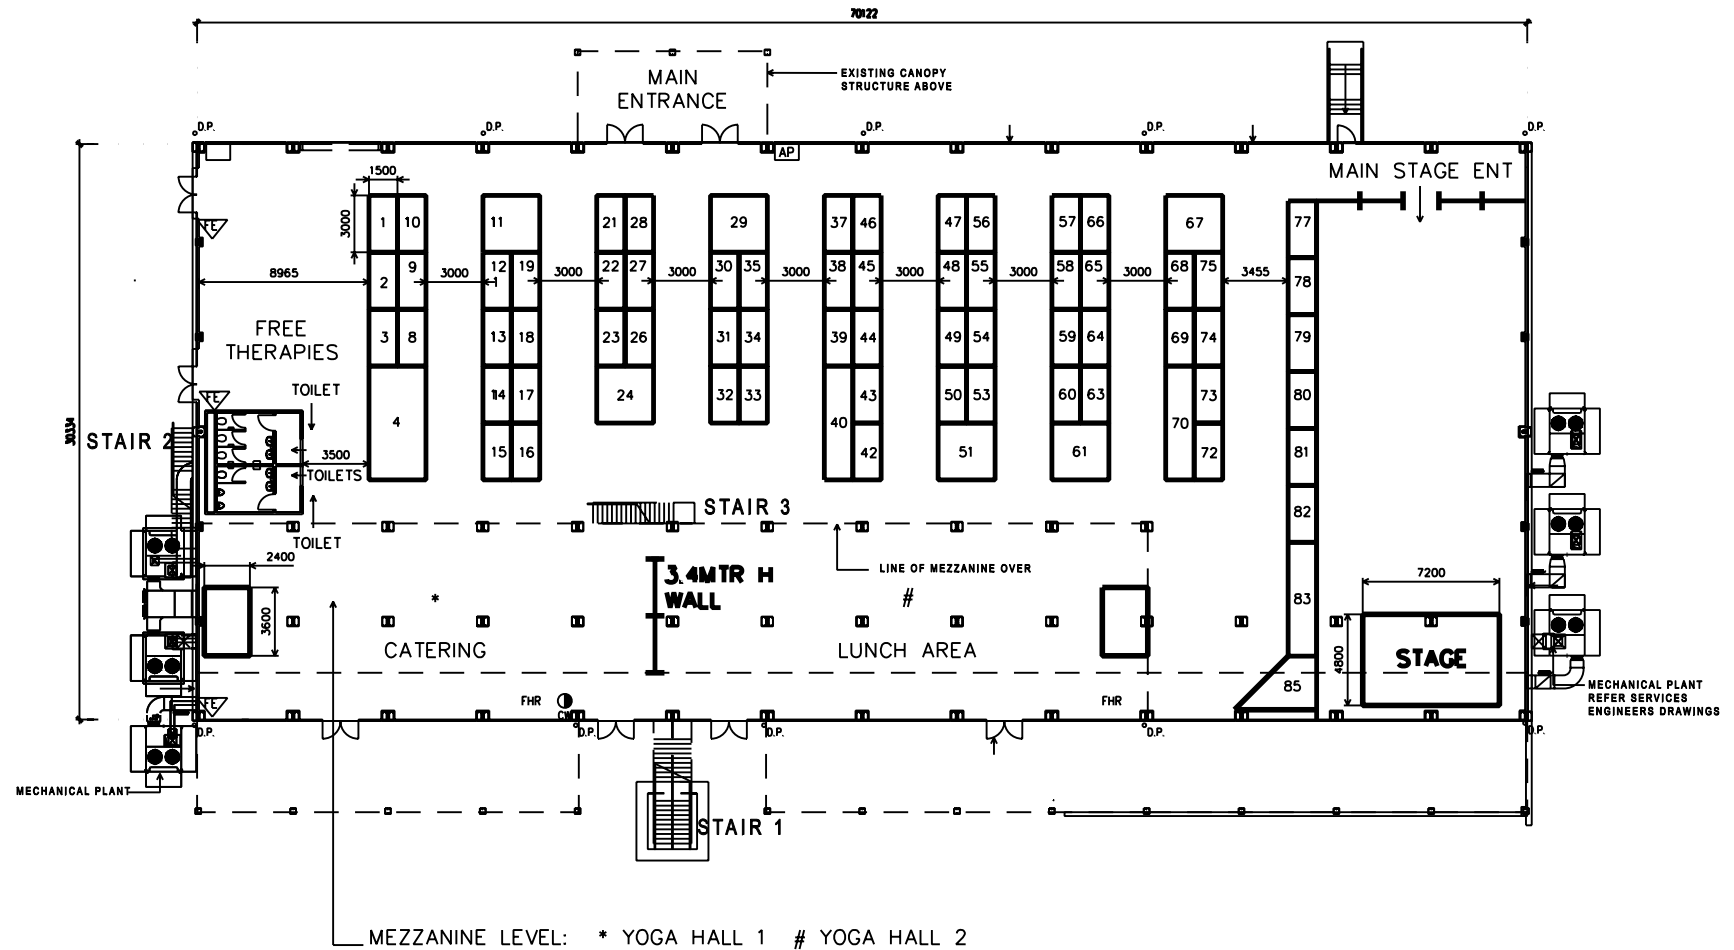

MECHANICAL PLANT  
REFER SERVICES  
ENGINEERS DRAWINGS

		YOGA EXPO 2008		
		MELBOURNE SHOWGROUND TOWN SQUARE HOECKER		
DWG NO:	DRAWN BY: MN	DATE: 120608	SCALE: NTS	<small>This artwork has been produced by and is the sole and exclusive property of the Exhibition Group Pty Ltd who reserve the rights of reproduction of construction in any form whatsoever and to whom this design shall be returned for their own use. The receipt by you of this design shall be evidence of your acceptance of these conditions. COPYRIGHTS ALL RIGHTS RESERVED</small>
APVD BY:	FILE:	ARTWORK COPYRIGHT		
<small>PHONE: 02 9972 1900 FAX: 02 9972 1988</small>		<small>TOLERANCES - UNLESS OTHERWISE NOTED.</small>		
<small>TOLERANCES TO ONE DECIMAL +0.5</small>		<small>TOLERANCES TO TWO DECIMAL +0.1</small>		<small>ANGULAR TOLERANCE +1 DEG.</small>